


NO.	DATE	DESCRIPTION
1	09-22-06	START/UP SET
2	11-22-06	BID SET
3	11-22-06	HEALTH DEPT. COMMENTS
4	11-22-06	PLAN CHECK COMMENTS
5	12-22-06	OWNER CHANGES
6	03-27-07	ISSUE FOR CONSTRUCTION

PK-DAVE PRELIFT
DRAWN: RB
MARCH 27, 2007

ROOF PLAN

A2.01

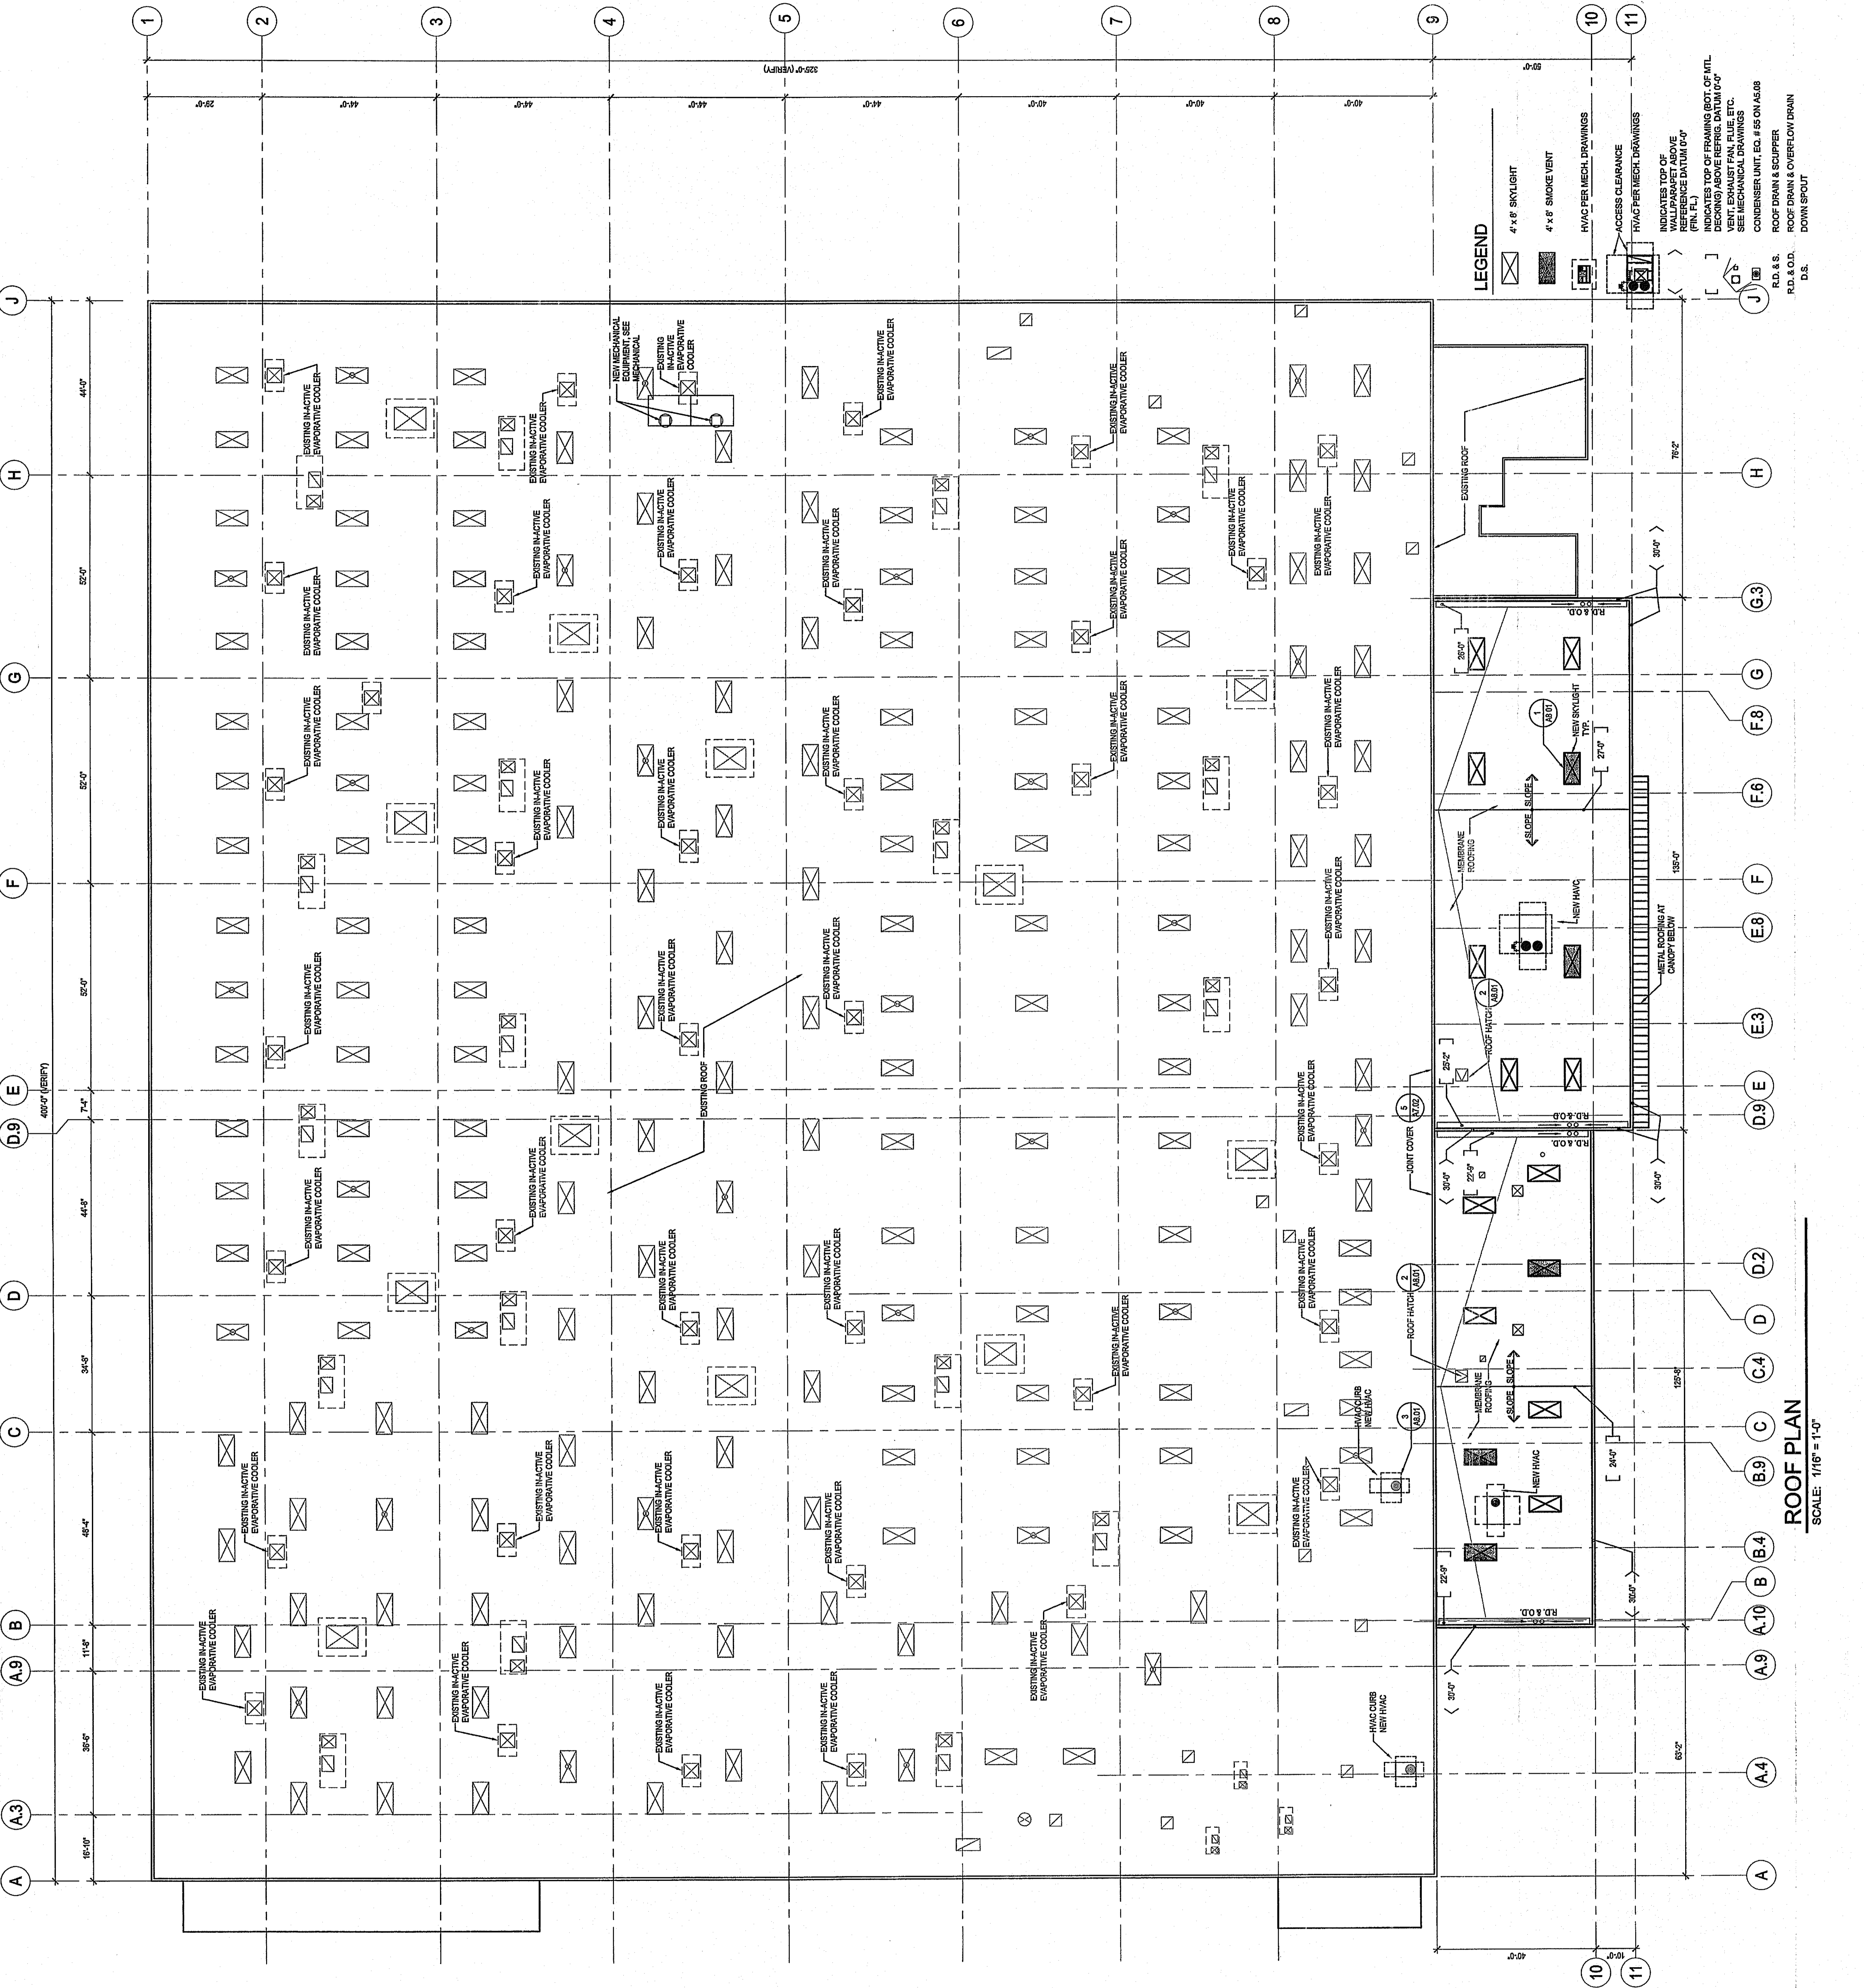

LEGEND

- 4 x 8 SKYLIGHT
- 4 x 8 SMOKE VENT
- H/W/C PER MECH. DRAWINGS
- ACCESS CLEARANCE
- H/W/C PER MECH. DRAWINGS
- INDICATES TOP OF WALL/PARAPET ABOVE FIN. FLOOR FINISH DATUM 0'-0"
- INDICATES TOP OF FRAMING (BOT. OF INTL DECKING) ABOVE REFRIG. DATUM 0'-0"
- VENT. EXHAUST FAN FLUE, ETC. SEE MECHANICAL DRAWINGS
- CONDENSER UNIT, E.C. #55 ON A5/B8
- ROOF DRAIN & SCUPPER
- DOWN SPOUT
- R.D. & S.
- D.S.

NOTES

- SEE A4.01 FOR SKYLIGHT LOCATIONS
- SEE MECH. FOR MECH. UNIT LOCATIONS
- SEE PLUMBING FOR CONTINUATION OF PARALLELERS. (CONNECT TO TIGHT-LINED STORM DRAIN SYSTEM)
- ALL MECH. UNITS TO BE COORDINATED WITH MECH. ENGINEER & SUPPLIER PRIOR TO CONSTRUCTION.
- ALL MECH. UNIT CURBS BY TAB.S.
- PAINT ALL EXPOSED PIPES AND STRUCTURAL STEEL. NO COPPER STEEL SHALL BE LEFT IN CONTACT WITH, OR EXPOSED TO WEATHER ABOVE THE GALVALUMS ROOF.
- GAUVANIC ACTION BETWEEN THE TWO (2) MATERIALS.

ROOF PLAN

SCALE: 1/16" = 1'-0"